


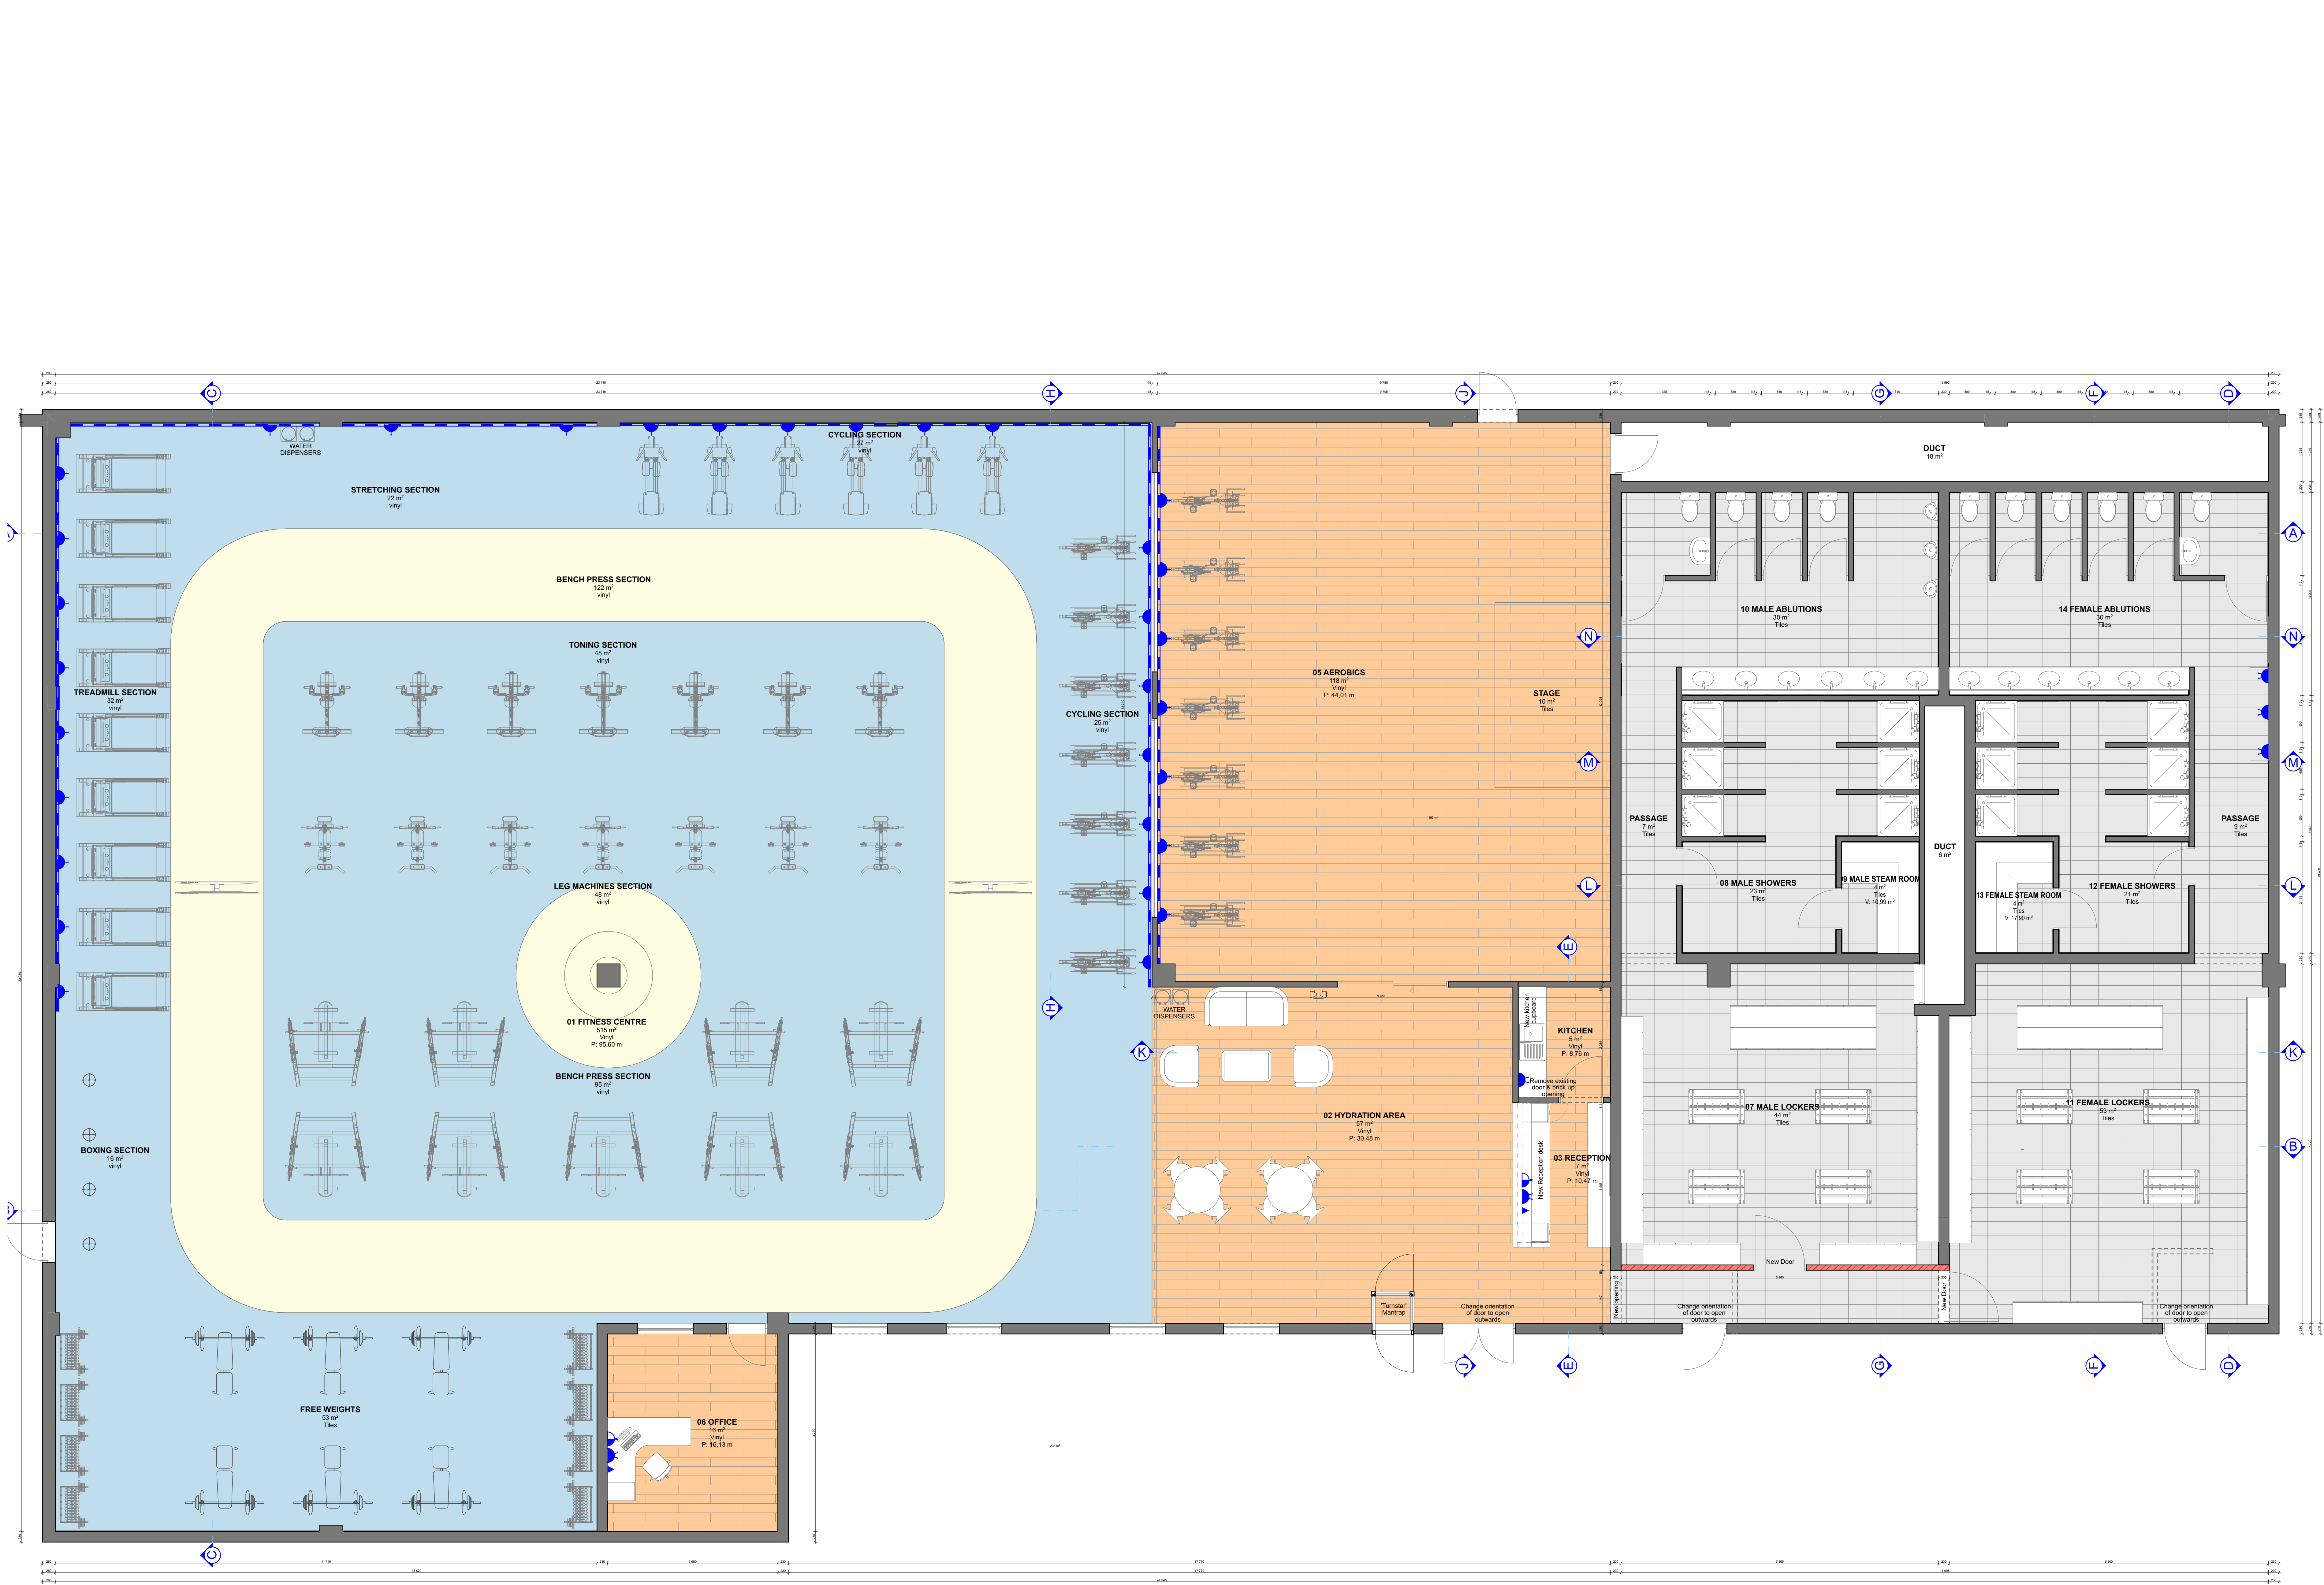

0.

Ground Floor Plan

1:50

LEGEND

	EXISTING WALLS & COLUMNS
	NEW WALLS
	PORCELAIN TILES
	BELGOTEX LUXURY VINYL TILES
	PEDESTRA VINYL TILES (COLOUR 01)
	PEDESTRA VINYL TILES (COLOUR 02)

ELECTRICAL LEGEND

	POWER SKIRTING
	16A SINGLE SOCKET
	16A SINGLE SOCKET IN CEILING
	16A DOUBLE SOCKET
	16A DOUBLE SOCKET IN CEILING
	16A DOUBLE PC SOCKET
	DATA POINT
	DATA POINT IN CEILING
	TELEPHONE POINT
	SINGLE LIGHT SWITCH

REV	DATE ISSUED	DESCRIPTION	BY
-----	-------------	-------------	----

REVISIONS

CLIENT:



Name: Date: 2021/08/06
Signature: Status:

ARCHITECTS:



Gauteng Office
Acorn Village 16
Cnr Bond & Kent Avenue
Ferndale, Randburg
2195
Tel: 087 073 5845
Fax: 086 5628 288

Name: Date: 2021/08/06
Signature: Status:

PROJECT TITLE:

SABC FITNESS CENTRE

DRAWING DESCRIPTION

FLOOR PLAN LAYOUT

DATE ISSUED: 2021/08/06 DRAWN: CHECKED: SIZE: A0 (1189x841)

PURPOSE: FOR INFORMATION

DWG NO: A-201	REVISION: CD00
-------------------------	--------------------------